
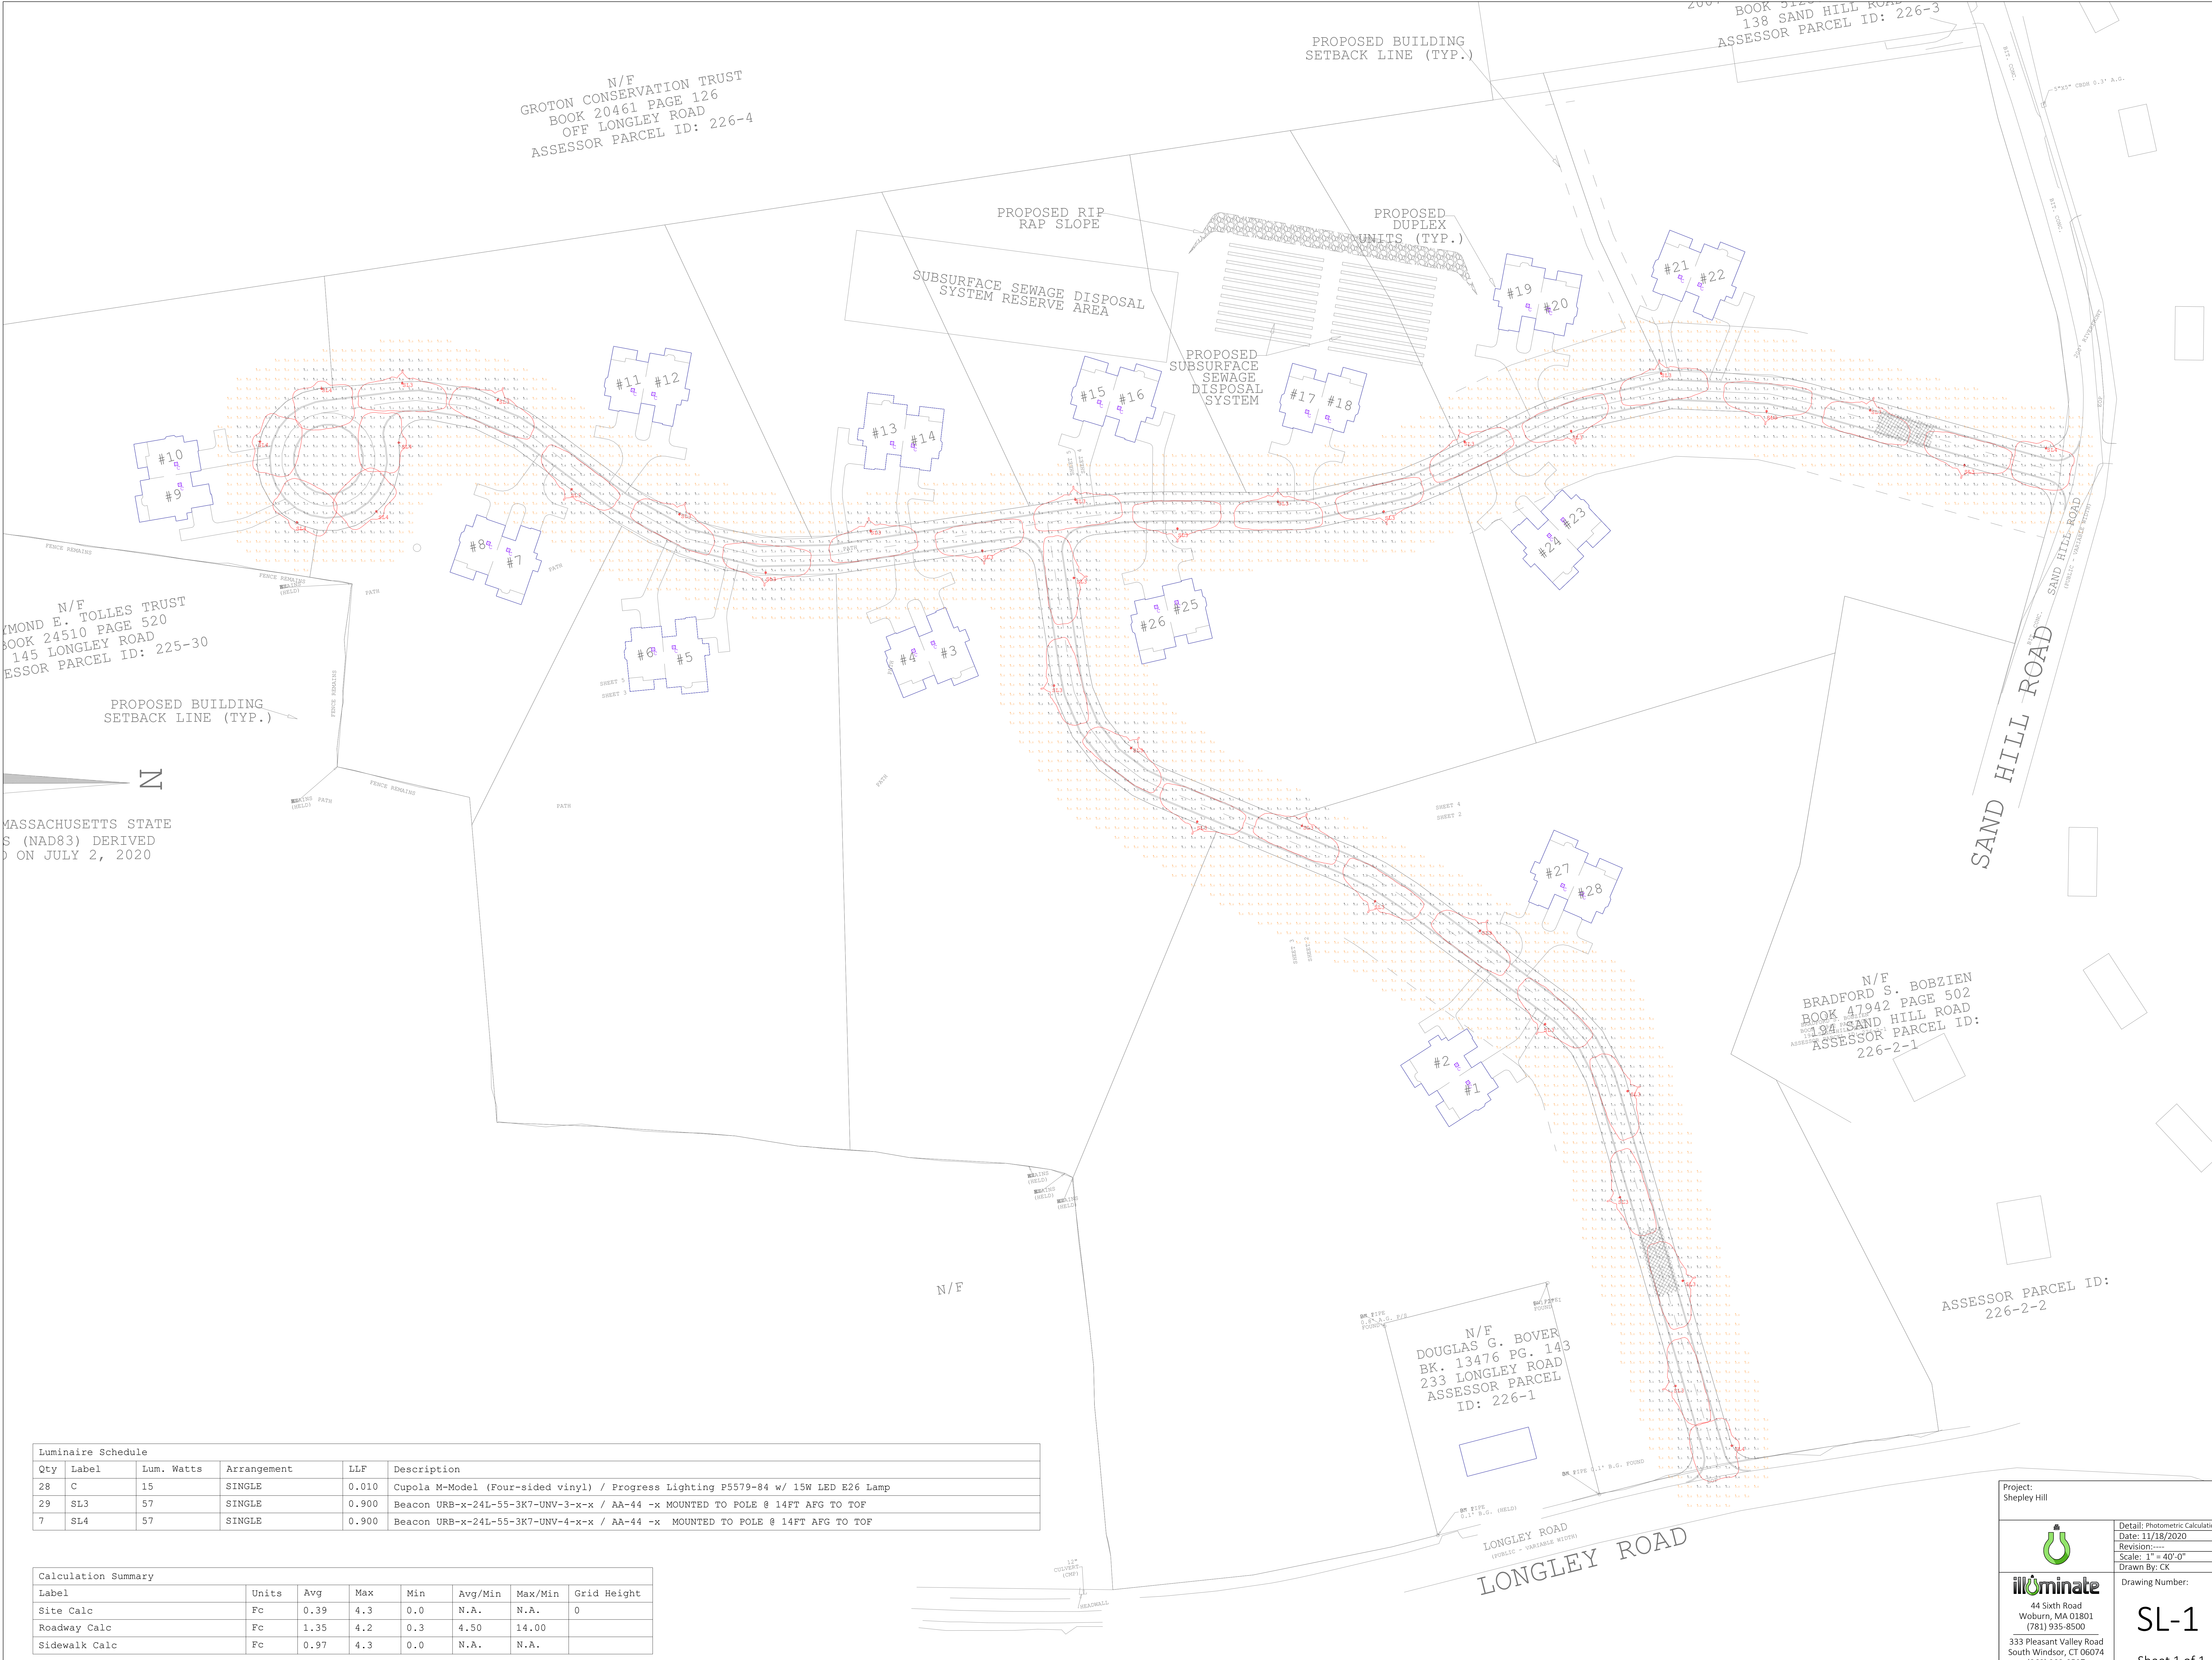


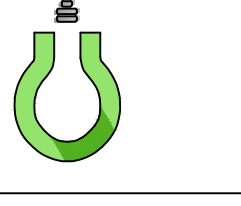

Luminaire Schedule					
Qty	Label	Lum. Watts	Arrangement	LLF	Description
28	C	15	SINGLE	0.010	Cupola M-Model (Four-sided vinyl) / Progress Lighting P5579-84 w/ 15W LED E26 Lamp
29	SL3	57	SINGLE	0.900	Beacon URB-x-24L-55-3K7-UNV-3-x-x / AA-44 -x MOUNTED TO POLE @ 14FT AFG TO TOF
7	SL4	57	SINGLE	0.900	Beacon URB-x-24L-55-3K7-UNV-4-x-x / AA-44 -x MOUNTED TO POLE @ 14FT AFG TO TOF

Calculation Summary							
Label	Units	Avg	Max	Min	Avg/Min	Max/Min	Grid Height
Site Calc	Fc	0.39	4.3	0.0	N.A.	N.A.	0
Roadway Calc	Fc	1.35	4.2	0.3	4.50	14.00	
Sidewalk Calc	Fc	0.97	4.3	0.0	N.A.	N.A.	

Project:
Shepley Hill


44 Sixth Road
Woburn, MA 01801
(781) 935-8500
333 Pleasant Valley Road
South Windsor, CT 06074
(860) 282-0597

Detail: Photometric Calculation

Date: 11/18/2020

Revision: 1

Scale: 1" = 40'-0"

Drawn By: CK

Drawing Number:
SL-1

Sheet 1 of 1