


500 Main Street
Groton, MA

Owner

500 MG, LLC
Omni Properties
6 Lyberty Way, Suite 203
Westford, MA 01886

Landscape Architect

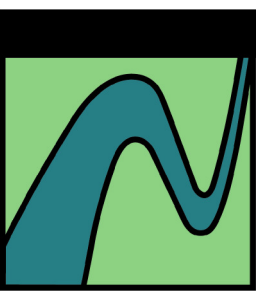

Radner Design
Associates, Inc.
3 Allied Drive, Suite 303
Dedham, MA 02026
508-736-6144
www.RadnerDesign.com

LANDSCAPE ARCHITECTURE
WOLF
PO Box 748
Groton, MA 01450
617.676.8847
www.wolflandscape.com

△ LIGHTING NOTE-ZBA REVIEW 07/21/2023

Revision: _____
Drawn: kc
Checked by: mr
Scale: AS SHOWN
Issue: _____

Sheet Name:
Light Images, Schedule
& Elevation


Project No.:
22-11

Issue Date:
07/15/2023

Sheet No.:

L4

Drawings and Design © 2023 Radner Design Associates, Inc.

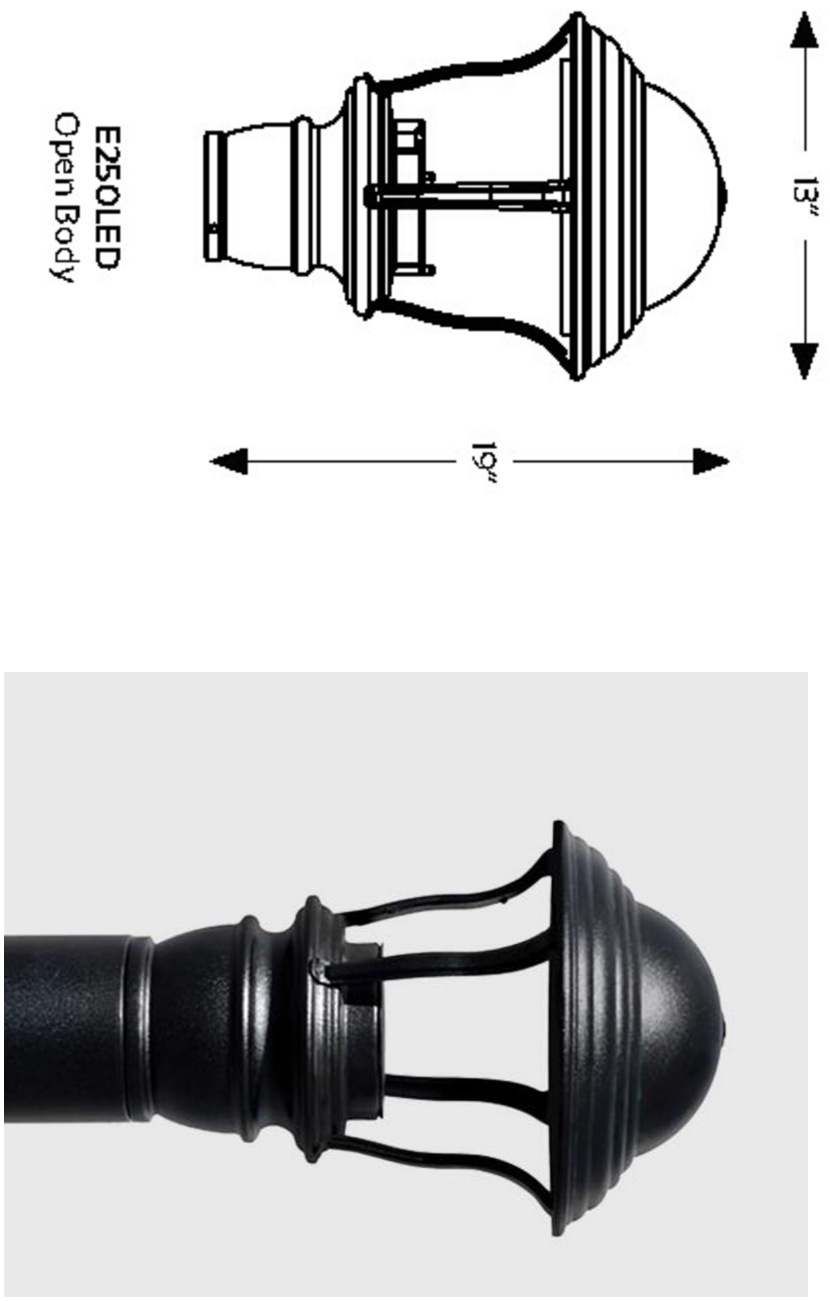

PT1, PT2, PT3 – PEDESTRIAN LIGHT FIXTURE

SCALE: NTS




SL1 & SL3 – PARKING LOT LIGHT FIXTURE

SCALE: NTS

Luminaire Schedule									
Symbol	Qty	Size	Light	Mounting	Height	Beam Angle	Light Output	Life Span	Notes
SL1	3	3000K	LED	1000'	1000'	120°	1000'	1000'	1000'
PT1	3	3000K	LED	1000'	1000'	120°	1000'	1000'	1000'
PT2	3	3000K	LED	1000'	1000'	120°	1000'	1000'	1000'
PT3	3	3000K	LED	1000'	1000'	120°	1000'	1000'	1000'
SL2	3	3000K	LED	1000'	1000'	120°	1000'	1000'	1000'
SL3	3	3000K	LED	1000'	1000'	120°	1000'	1000'	1000'

LUMINAIRE SCHEDULE

SCALE: NTS

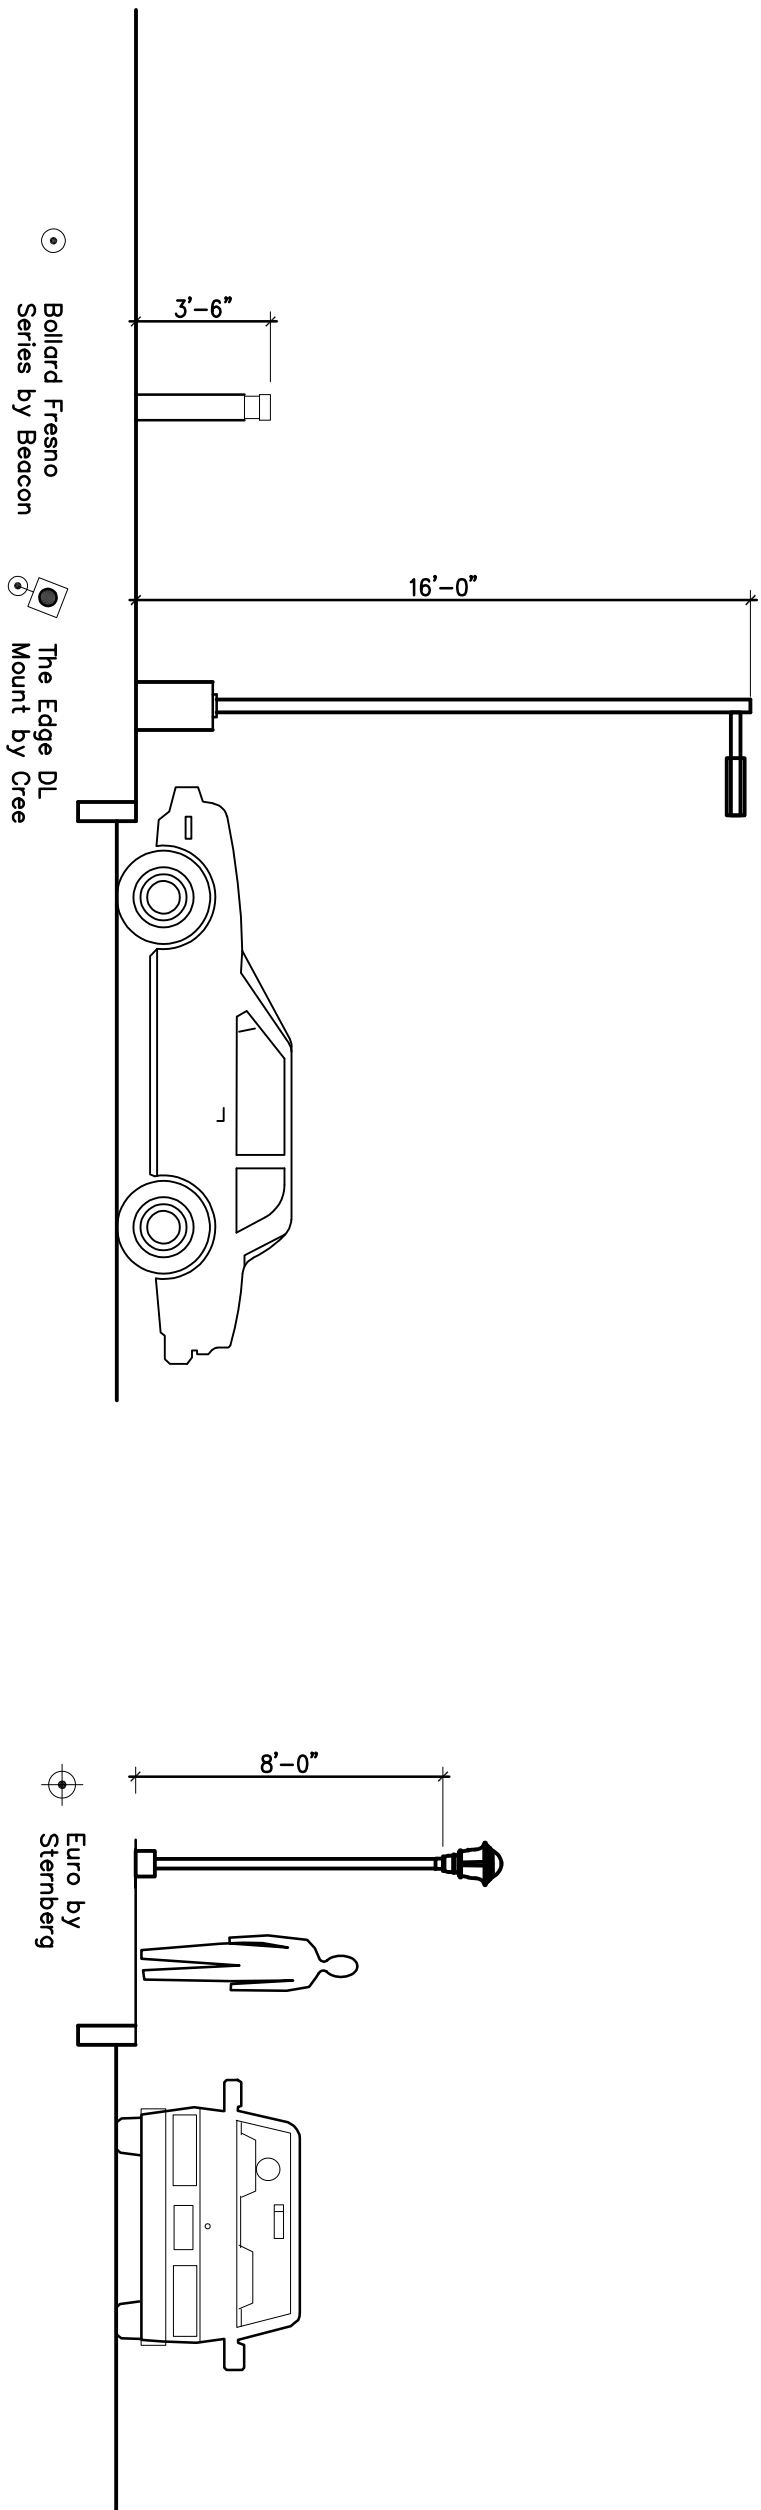

SITE LIGHT ELEVATION

SCALE: NTS

NOTE: SL1 AND SL3 (PARKING LOT LIGHT FIXTURES) WILL BE DIMMED TO 70% LUMINOSITY BETWEEN THE HOURS OF 11pm AND 6am

1